


SYMBOLS

-  INTERIOR LIGHT
-  BREAKER PANEL
-  INTERIOR SUPPORT POST
-  SMOKE & CO2 DETECTOR
-  FIRE EXTINGUISHER
-  ELECTRICAL OUTLET
-  EXTERIOR LIGHT
-  THERMOSTAT
-  EXHAUST FAN
-  COMMUNICATION OUTLET
-  SENSOR-LIGHT OR GAS
-  EXIT LIGHT WITH EMERGENCY LIGHT
-  SINGLE FIXTURE WATER HEATER
-  ELECTRICAL SWITCH

REVISION HISTORY				
REV	DESCRIPTION	DATE	BY	CHECKED
A	ISSUED FOR REVIEW	10/30/2023	JLL	DO
B	UPDATED PER COMMENTS	11/1/2023	JLL	DO

NOTES:
 -PRIOR TO ALL WORK, REMOVE INTERIOR FURNISHINGS.
 -SHOOT PINS INTO WALLS AND CEILING EVERY 12"
 -COLD GALVANIZE PINS AFTER INSTALLED
 -BLAST EXTERIOR ROOF & WALLS
 -MASK OFF ALL DOOR GASKETS
 -PRIME W/ CM15 FRONT FACE WHITE

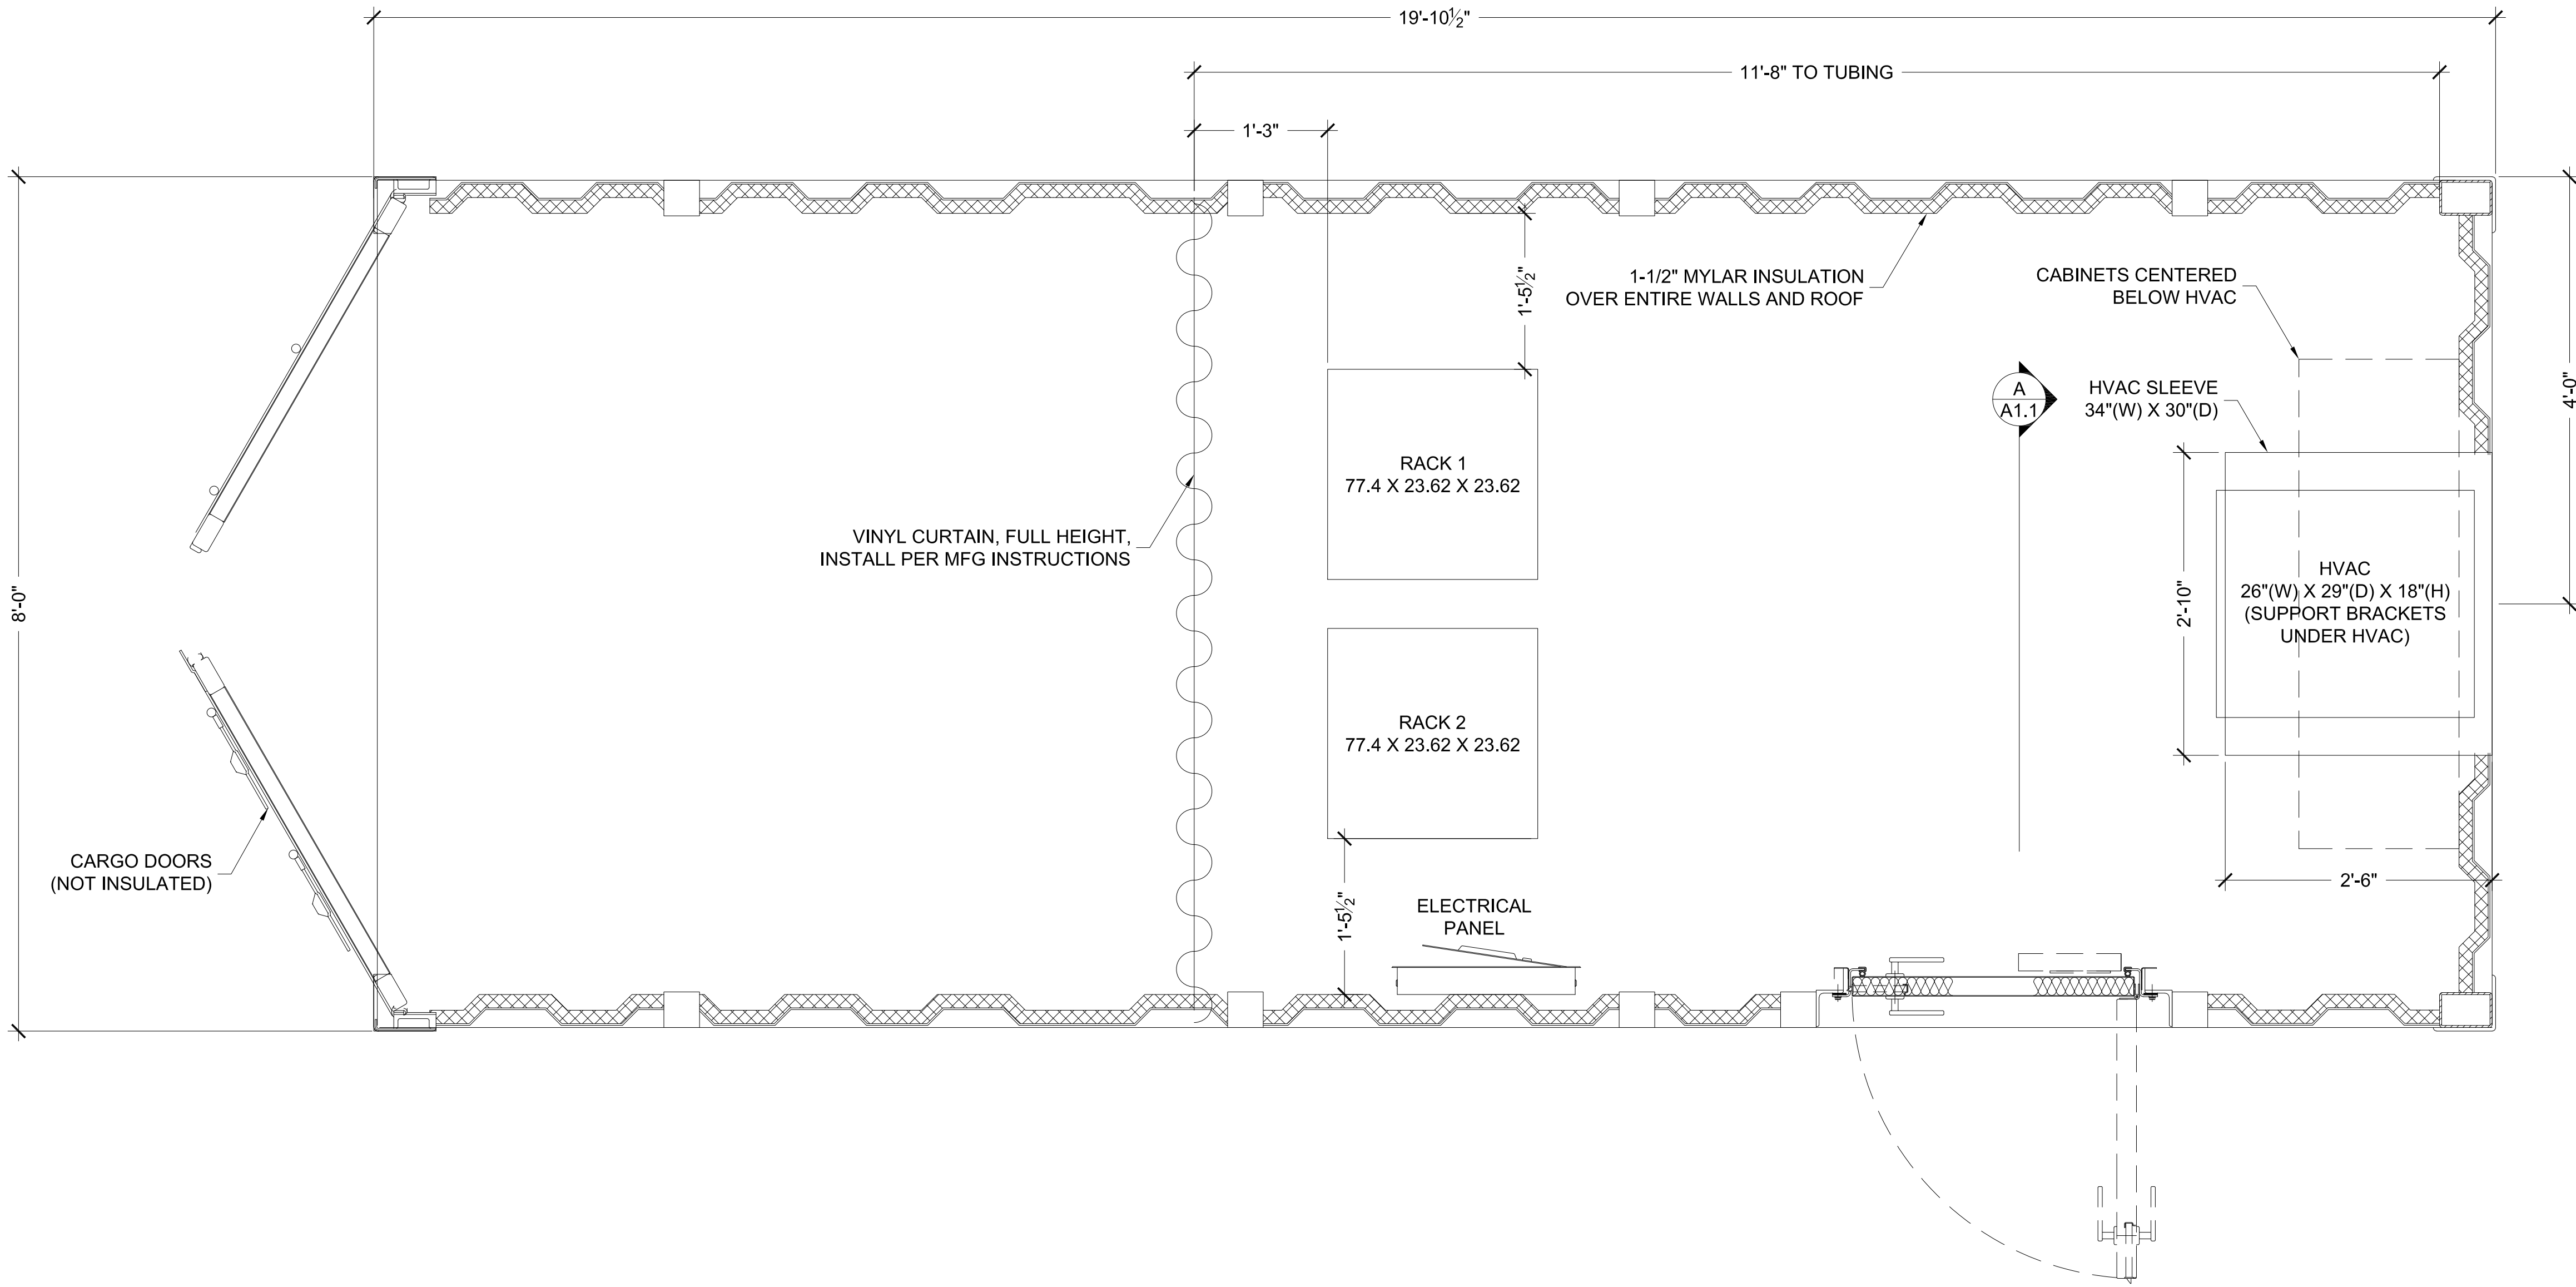

THE INFORMATION CONTAINED HEREIN IS PROPRIETARY TO REDGUARD, LLC AND SHALL NOT BE REPRODUCED OR DISCLOSED IN WHOLE OR IN PART OR USED FOR ANY PURPOSE EXCEPT WHEN SUCH USER POSSESSES DIRECT WRITTEN AUTHORIZATION FROM REDGUARD, LLC

EXPORT CONTROLLED DATA: THIS DOCUMENT MAY CONTAIN TECHNICAL INFORMATION WHOSE EXPORT IS GOVERNED BY THE UNITED STATES DEPARTMENTS OF COMMERCE AND STATE. IT IS THE RESPONSIBILITY OF THE RECIPIENT(S) OF THIS DRAWING TO ENSURE THAT ITS CONTENTS ARE CONTROLLED AS SUCH TO REMAIN IN COMPLETE COMPLIANCE WITH THE U.S. ARMS EXPORT CONTROL ACT, THE INTERNATIONAL TRAFFIC IN ARMS REGULATIONS, AND THE EXPORT ADMINISTRATION ACT.



ARMODA

2317 ENGINEERS RD.
 BELLE CHASSE, LA 70037
 PH: 855.733.4827
 FAX: 316.440.1800
 www.armoda.com

PXGEO SSH449 MOD

8' X 20' X 8'-6"

FLOOR PLAN

CP#: A-003

PROJECT MANAGER: JO

DRAWN BY: JLL

DATE: 10/30/2023

FILE: A-003 8X20 FP

SCALE: 1" = 1'-0"




REVISION: B

SHEET: A1.1


**A-003 PXGEO SSH449 MOD
 FLOOR PLAN
 8' X 20' X 8'-6"**

SCALE LISTED IS VALID
 ONLY FOR "D" SIZE PAPER
 (36" X 24")

SYMBOLS

-  INTERIOR LIGHT
-  BREAKER PANEL
-  INTERIOR SUPPORT POST
-  SMOKE & CO2 DETECTOR
-  FIRE EXTINGUISHER
-  ELECTRICAL OUTLET
-  EXTERIOR LIGHT
-  THERMOSTAT
-  EXHAUST FAN
-  COMMUNICATION OUTLET
-  SENSOR-LIGHT OR GAS
-  EXIT LIGHT WITH EMERGENCY LIGHT
-  SINGLE FIXTURE WATER HEATER
-  ELECTRICAL SWITCH

REVISION HISTORY				
REV	DESCRIPTION	DATE	BY	CHECKED
A	ISSUED FOR REVIEW	10/30/2023	JLL	DO
B	UPDATED PER COMMENTS	11/1/2023	JLL	DO

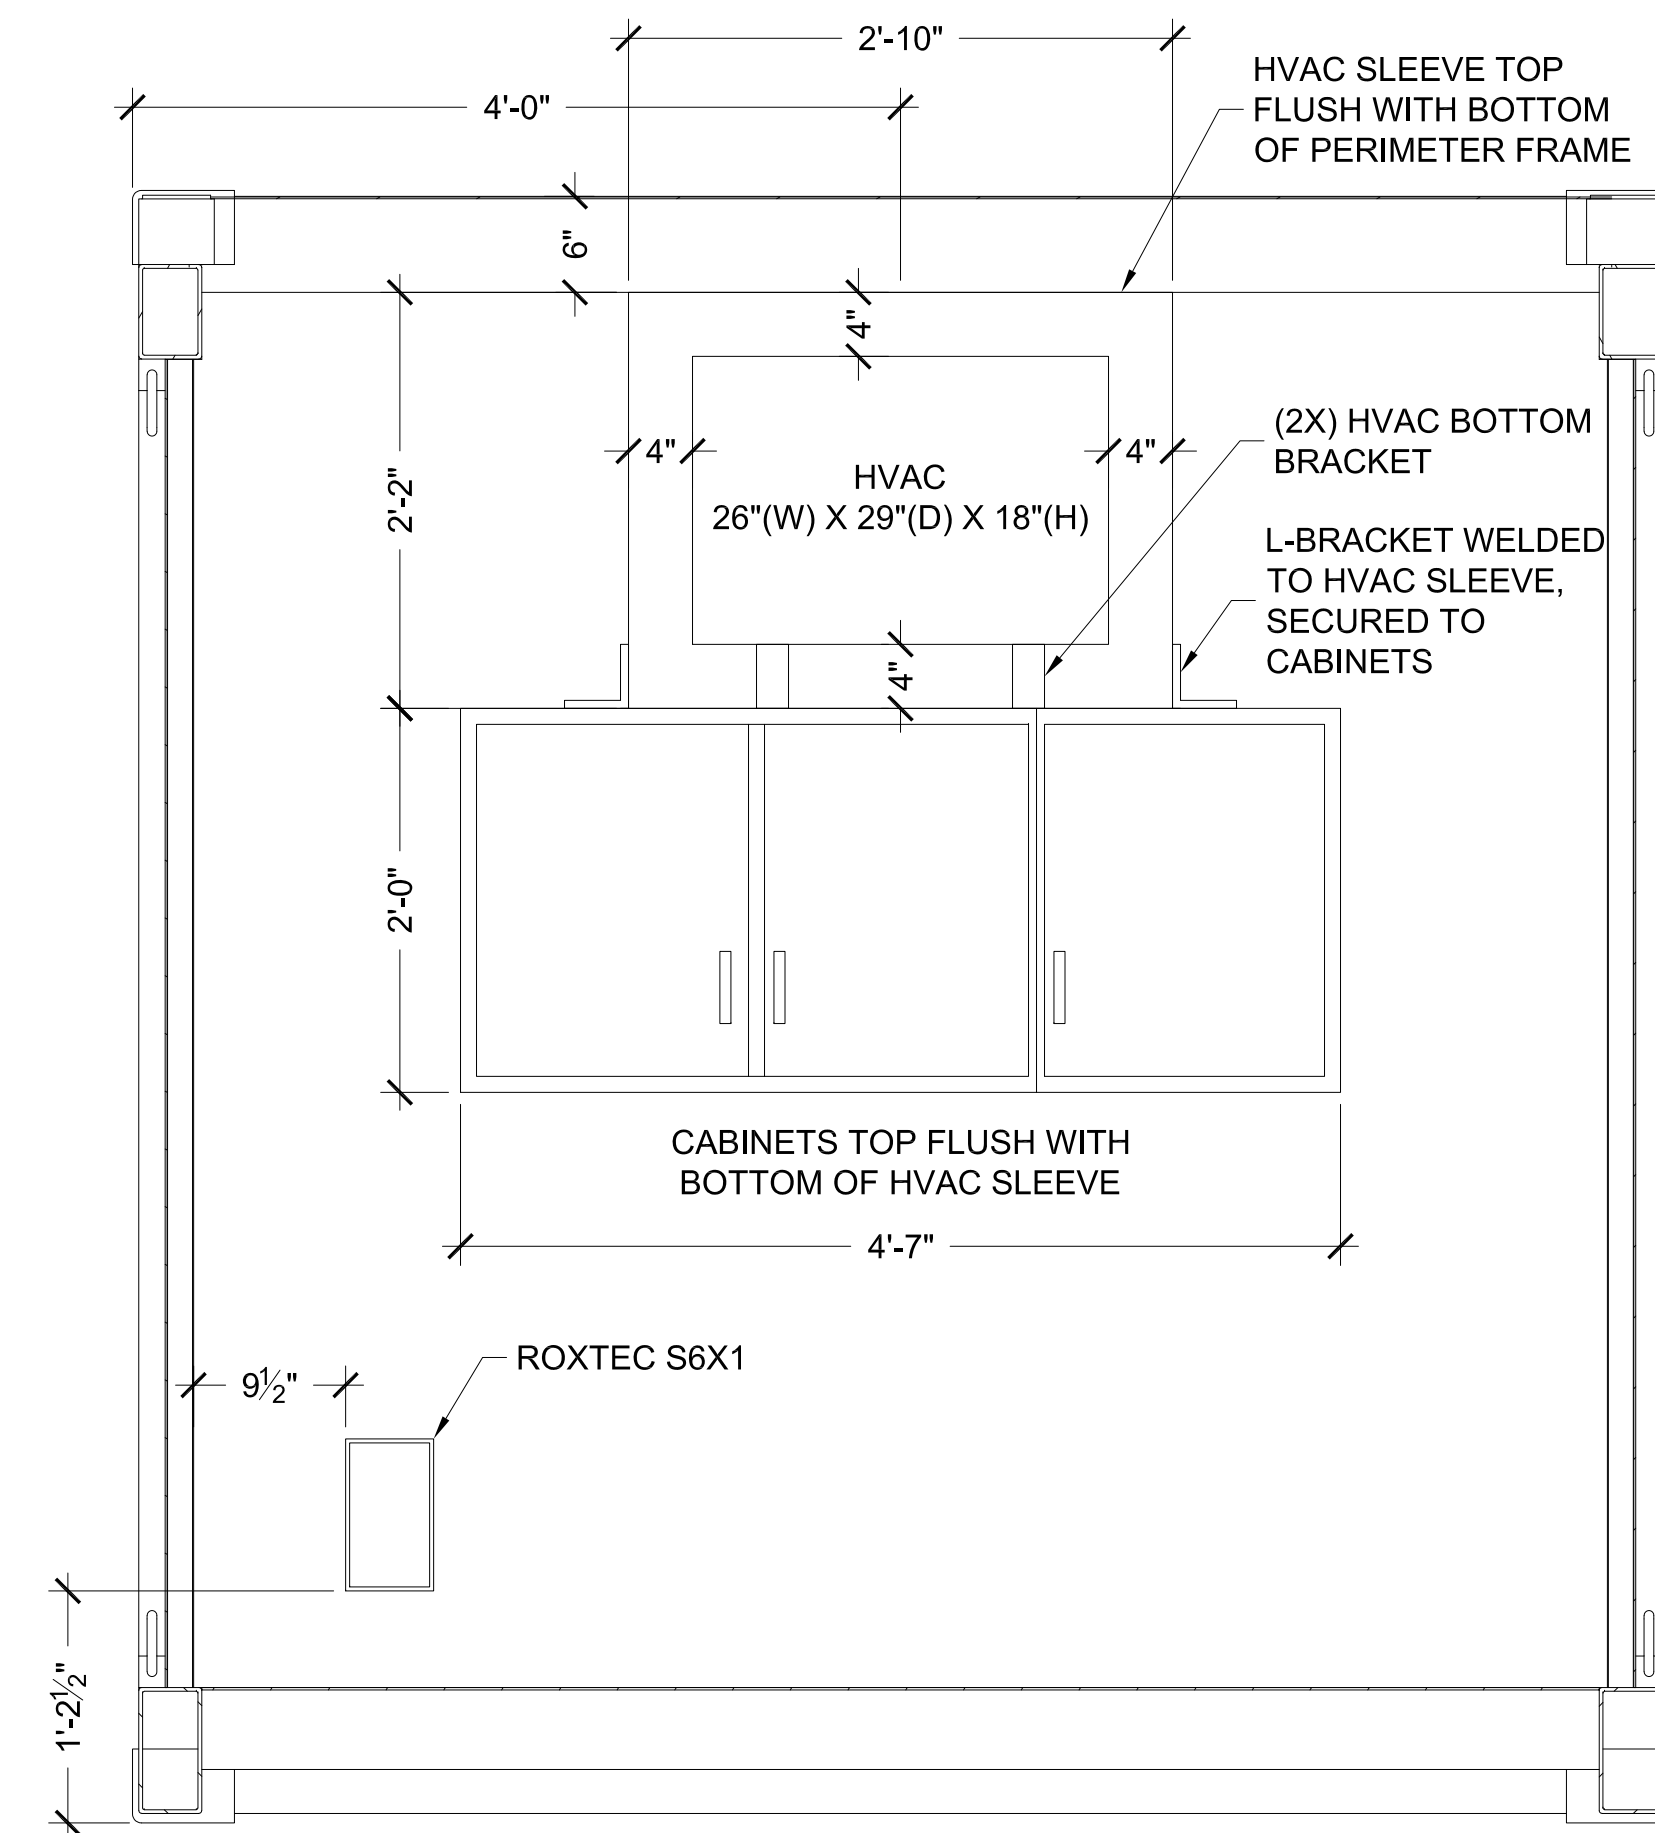

A HVAC WALL INTERIOR ELEVATION
A1.1 NTS

**A-003 PXGEO SSH449 MOD
INTERIOR ELEVATION
8' X 20' X 8'-6"**

THE INFORMATION CONTAINED HEREIN IS PROPRIETARY TO REDGUARD, LLC AND SHALL NOT BE REPRODUCED OR DISCLOSED IN WHOLE OR IN PART OR USED FOR ANY PURPOSE EXCEPT WHEN SUCH USER POSSESSES DIRECT WRITTEN AUTHORIZATION FROM REDGUARD, LLC

EXPORT CONTROLLED DATA: THIS DOCUMENT MAY CONTAIN TECHNICAL INFORMATION WHOSE EXPORT IS GOVERNED BY THE UNITED STATES DEPARTMENTS OF COMMERCE AND STATE. IT IS THE RESPONSIBILITY OF THE RECIPIENT(S) OF THIS DRAWING TO ENSURE THAT ITS CONTENTS ARE CONTROLLED AS SUCH TO REMAIN IN COMPLETE COMPLIANCE WITH THE U.S. ARMS EXPORT CONTROL ACT, THE INTERNATIONAL TRAFFIC IN ARMS REGULATIONS, AND THE EXPORT ADMINISTRATION ACT.



ARMODA

2317 ENGINEERS RD.
BELLE CHASSE, LA 70037
PH: 855.733.4827
FAX: 316.440.1800
www.armoda.com

PXGEO SSH449 MOD

8' X 20' X 8'-6"

INTERIOR ELEVATION

CP#: A-003

PROJECT MANAGER: JO

DRAWN BY: JLL

DATE: 10/30/2023

FILE: A-003 8X20 FP

SCALE: NTS

REVISION: B

SHEET: A1.2

SCALE LISTED IS VALID
ONLY FOR "D" SIZE PAPER
(36" X 24")