 



**SYMBOLS**

-  INTERIOR LIGHT
-  BREAKER PANEL
-  INTERIOR SUPPORT POST
-  SMOKE & CO2 DETECTOR
-  FIRE EXTINGUISHER
-  ELECTRICAL OUTLET
-  EXTERIOR LIGHT
-  THERMOSTAT
-  EXHAUST FAN
-  COMMUNICATION OUTLET
-  SENSOR-LIGHT OR GAS
-  EXIT LIGHT WITH EMERGENCY LIGHT
-  SINGLE FIXTURE WATER HEATER
-  ELECTRICAL SWITCH

REVISION HISTORY				
REV	DESCRIPTION	DATE	BY	CHECKED
A	ISSUED FOR REVIEW	11/20/2023	JLL	DO
B	UPDATED CONTAINER SIZE	12/5/2023	JLL	DO
C	UPDATED PER COMMENTS	12/11/2023	JLL	DO
D	DOOR/ELECTRICAL PANEL REMOVED	12/14/2023	JLL	DO

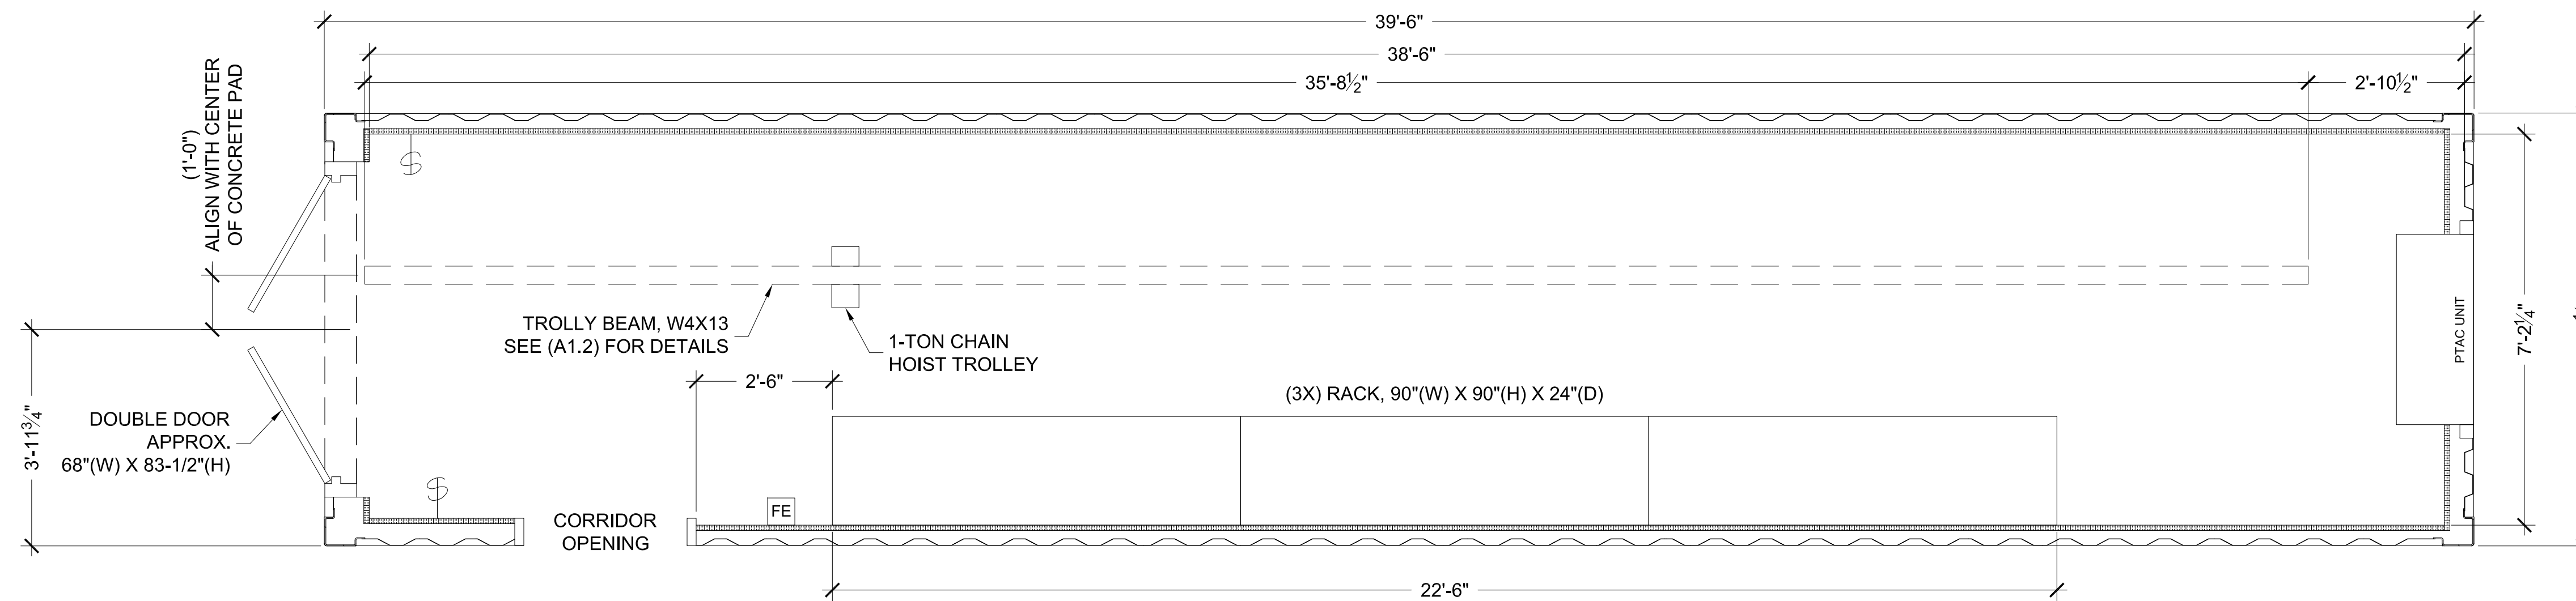

THE INFORMATION CONTAINED HEREIN IS PROPRIETARY TO REDGUARD, LLC AND SHALL NOT BE REPRODUCED OR DISCLOSED IN WHOLE OR IN PART OR USED FOR ANY PURPOSE EXCEPT WHEN SUCH USER POSSESSES DIRECT WRITTEN AUTHORIZATION FROM REDGUARD, LLC

EXPORT CONTROLLED DATA: THIS DOCUMENT MAY CONTAIN TECHNICAL INFORMATION WHOSE EXPORT IS GOVERNED BY THE UNITED STATES DEPARTMENTS OF COMMERCE AND STATE. IT IS THE RESPONSIBILITY OF THE RECIPIENT(S) OF THIS DRAWING TO ENSURE THAT ITS CONTENTS ARE CONTROLLED AS SUCH TO REMAIN IN COMPLETE COMPLIANCE WITH THE U.S. ARMS EXPORT CONTROL ACT, THE INTERNATIONAL TRAFFIC IN ARMS REGULATIONS, AND THE EXPORT ADMINISTRATION ACT.



**ARMODA**

2317 ENGINEERS RD.  
 BELLE CHASSE, LA 70037  
 PH: 855.733.4827  
 FAX: 316.440.1800  
 www.armoda.com

ENBRIDGE  
 7'-11 1/2" X 39'-6" X 9'-6"

FLOOR PLAN

CP#: A-006

PROJECT MANAGER: DP  
 DRAWN BY: JLL  
 DATE: 11/20/2023  
 FILE: A-006 8X40 FP  
 SCALE: 1/2" = 1'-0"  
 REVISION: D  
 SHEET: A1.1

**A-006 ENBRIDGE RP008 MONORAIL  
 FLOOR PLAN - MIDDLE BUILDING  
 7'-11 1/2" X 39'-6" X 9'-6"**

**NOTES:**  
 1. FINAL STEEL BEAM SIZES AND PLACEMENTS TO BE DETERMINED ON-SITE

**SCALE LISTED IS VALID  
 ONLY FOR "D" SIZE PAPER  
 (36" X 24")**